

**1 Floor Plan**  
1 : 50 / 118.69 sq.m

LOOSE FURNITURE SCHEDULE			
Key	Description	Quantity	Code
A	1000 Dia Round Table 750 high	16	T01
B	Teacher's Desk 2000x800mm L-Shaped	2	T02
C	Student's Chair 460 high	60	SIE0
D	Teacher's chair 525 high	2	S5
E	Pinboard 1200x1200	2	PB
E1	Pinboard 1800x1200	6	PB
F	Storage Press 900x450x1800 high	4	SC1


FIXED FURNITURE SCHEDULE			
Key	Description	Quantity	Code

SPECIALITY EQUIPMENT SCHEDULE			
Key	Description	Quantity	Code
AA	Acoustic Folding Wall	1	AFW

Post Primary School Room Layouts:			Dwg. Title
<b>Interconnecting Classrooms (x2)</b>			<b>Floor Plan</b>
Dwg. No.	Rev. No.	Scale	Date
<b>2-1</b>		<b>1 : 50 @ A3</b>	<b>Jan '17</b>




**Department of Education & Skills**  
Planning and Building Unit, Portlaoise Road, Tullamore, County Offaly, R35 Y2N5.  
[www.education.ie](http://www.education.ie) / [www.energineducation.ie](http://www.energineducation.ie)

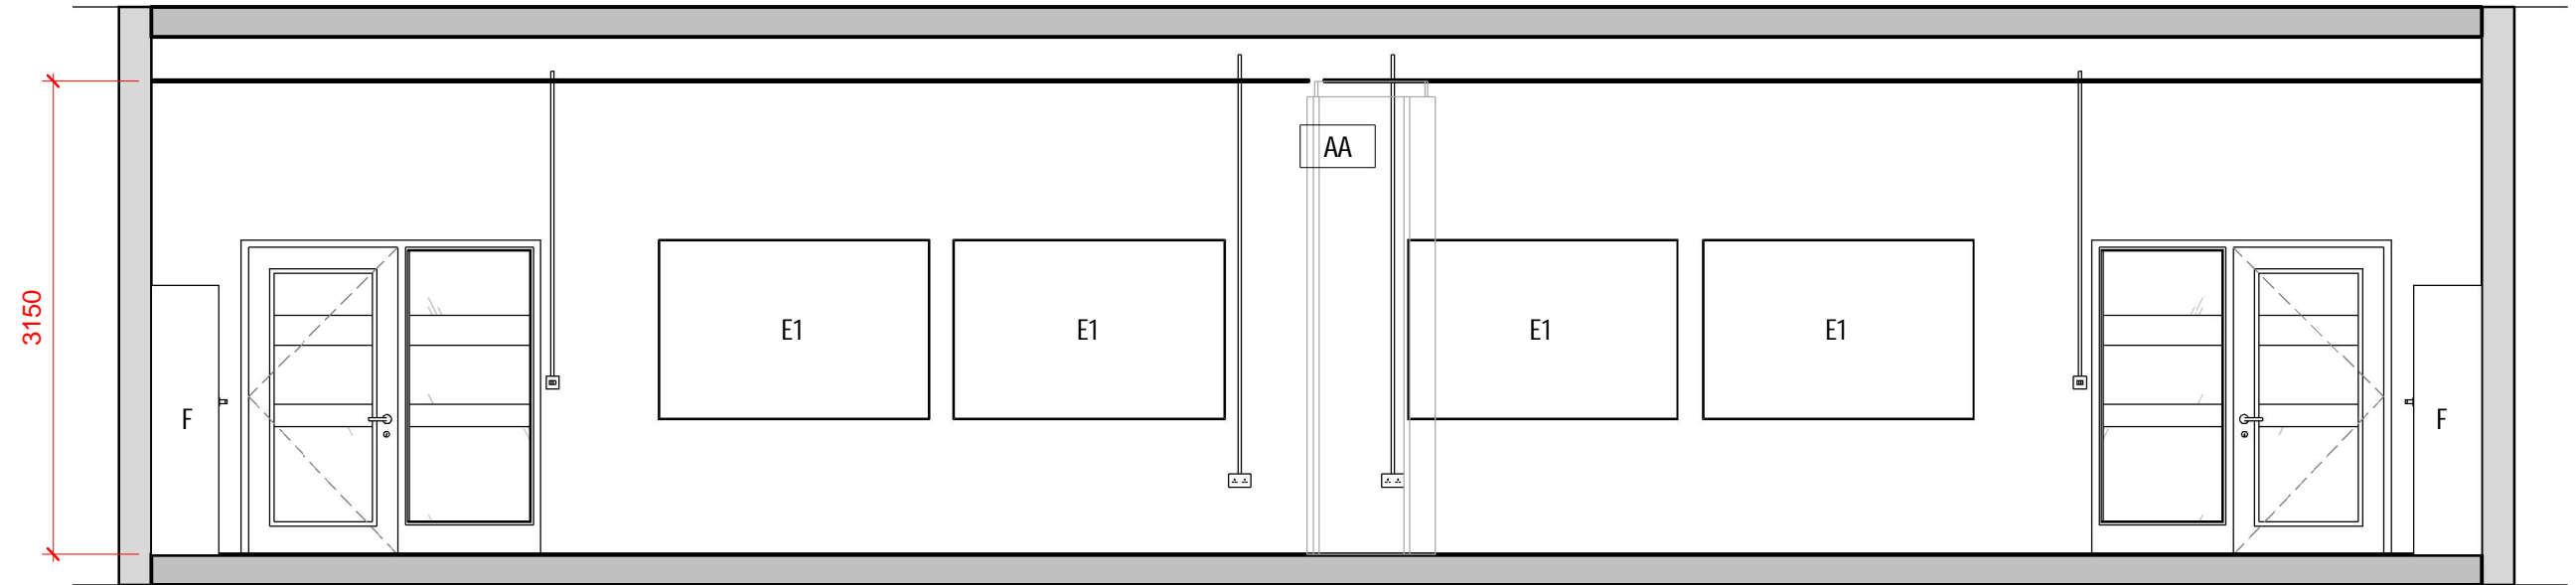


**1** Elevation AA  
1 : 50




**2** Elevation BB  
1 : 50

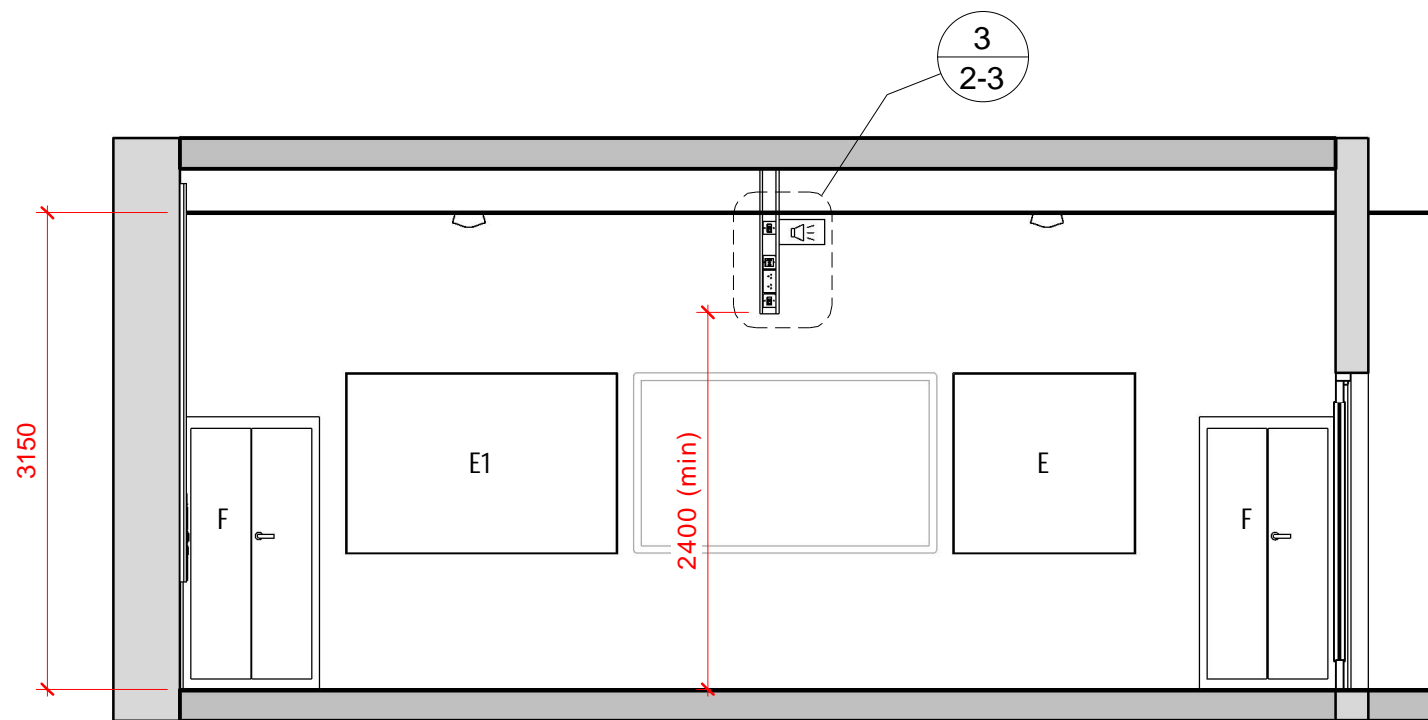


**1 Elevation CC**  
1 : 50

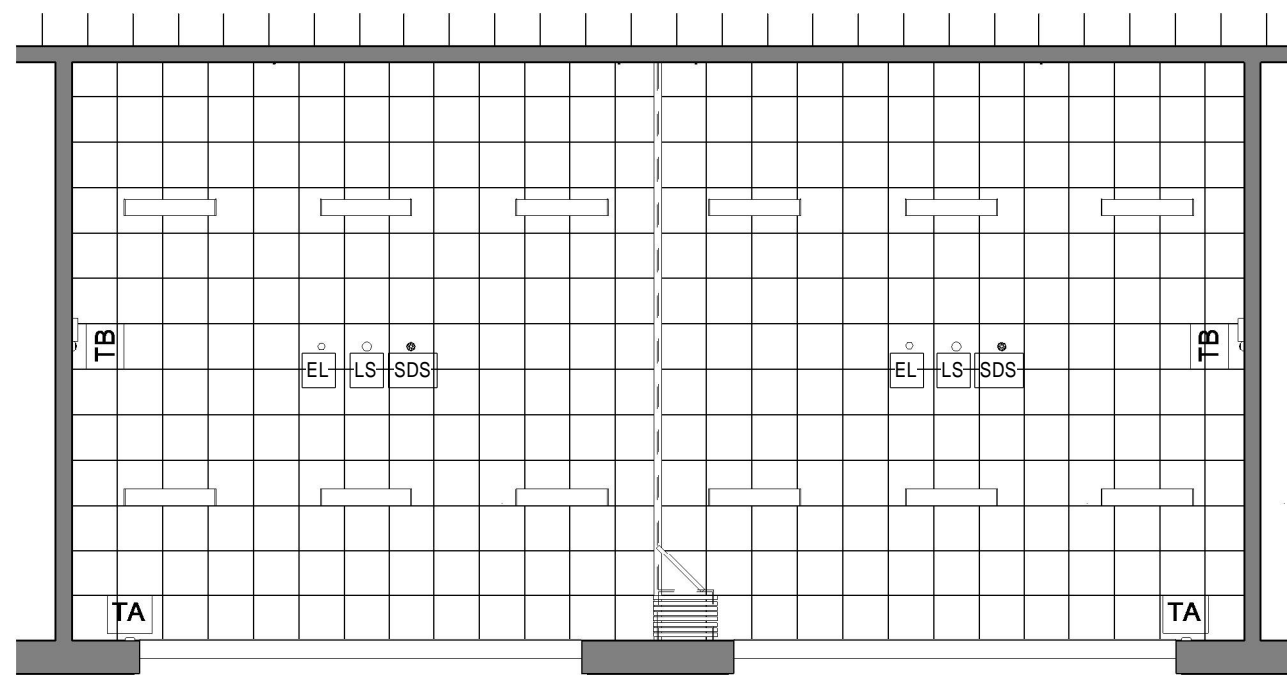

**4 Indicative Ceiling Plan**  
1 : 100 / 300 lux

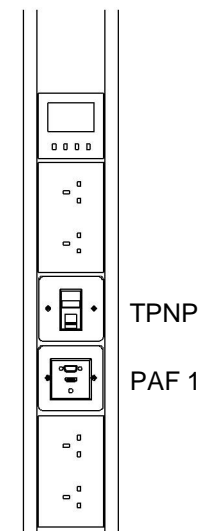

**2 TA - Trunking "A"**  
1 : 10

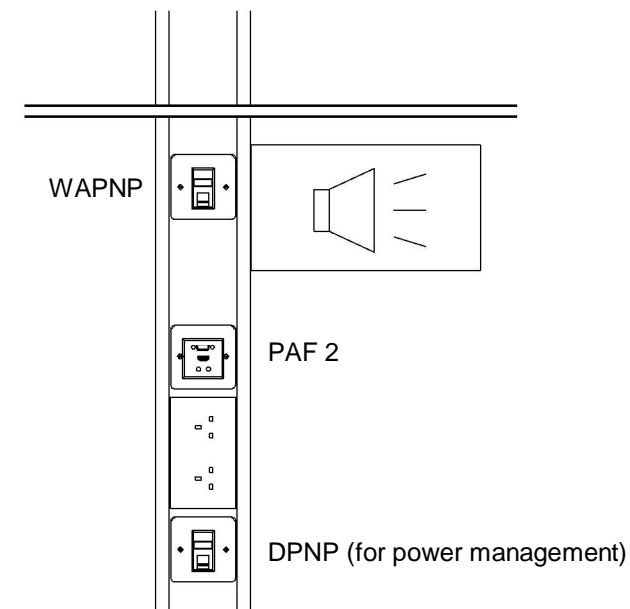

**3 TB - Trunking "B"**  
1 : 10

BUILDING SERVICES LEGEND		
Description	Qty.	
Data Projector Network Point (DPNP)	2	
Daylight Sensor with Absence Detector	2	
Emergency Lighting	2	
Light Switch 3 Gang	2	
PA Loudspeaker (One Way)	2	
Projector/Audio In Faceplate	2	
Projector/Audio-out Faceplate	2	
Smoke Detector / Sounder	2	
Socket Twin 13A Unswitched	8	
Teacher Position Network Point (TPNP)	2	
Thermostat Control	2	
Wireless Access Position Network Point (WAPNP)	2	

INDICATIVE LIGHTING SCHEDULE	
Description	Qty.
Surface Mounted Fluorescent	12

