

1 Floor Plan
1 : 50 / 88.60 sq.m

LOOSE FURNITURE SCHEDULE			
Key	Description	Quantity	Code
A	Student Desk 800x600x760mm	24	T2
B	Teacher's L Shaped Desk	1	T03
C	White Board	1	CBS/M
D	Teacher's chair 525 high	1	S5
E	Pinboard 1800x1200	4	PB
F	Steel Press 1200 x 610 x 2100 high	1	MW2
G	Student High Stool 660h	24	S2H

FIXED FURNITURE SCHEDULE			
Key	Description	Quantity	Code
1	625 Wide Worktop at height of 750	1	WT


SPECIALITY EQUIPMENT SCHEDULE			
Key	Description	Quantity	Code

Post Primary School Room Layouts:		Dwg. Title	
Technical Graphics Room		Floor Plan	
Dwg. No. 7-1	Rev. No.	Scale 1 : 50 @ A3	Date Jan '17




Department of Education & Skills


Planning and Building Unit, Portlaoise Road, Tullamore, County Offaly, R35 Y2N5.
www.education.ie / www.energineducation.ie

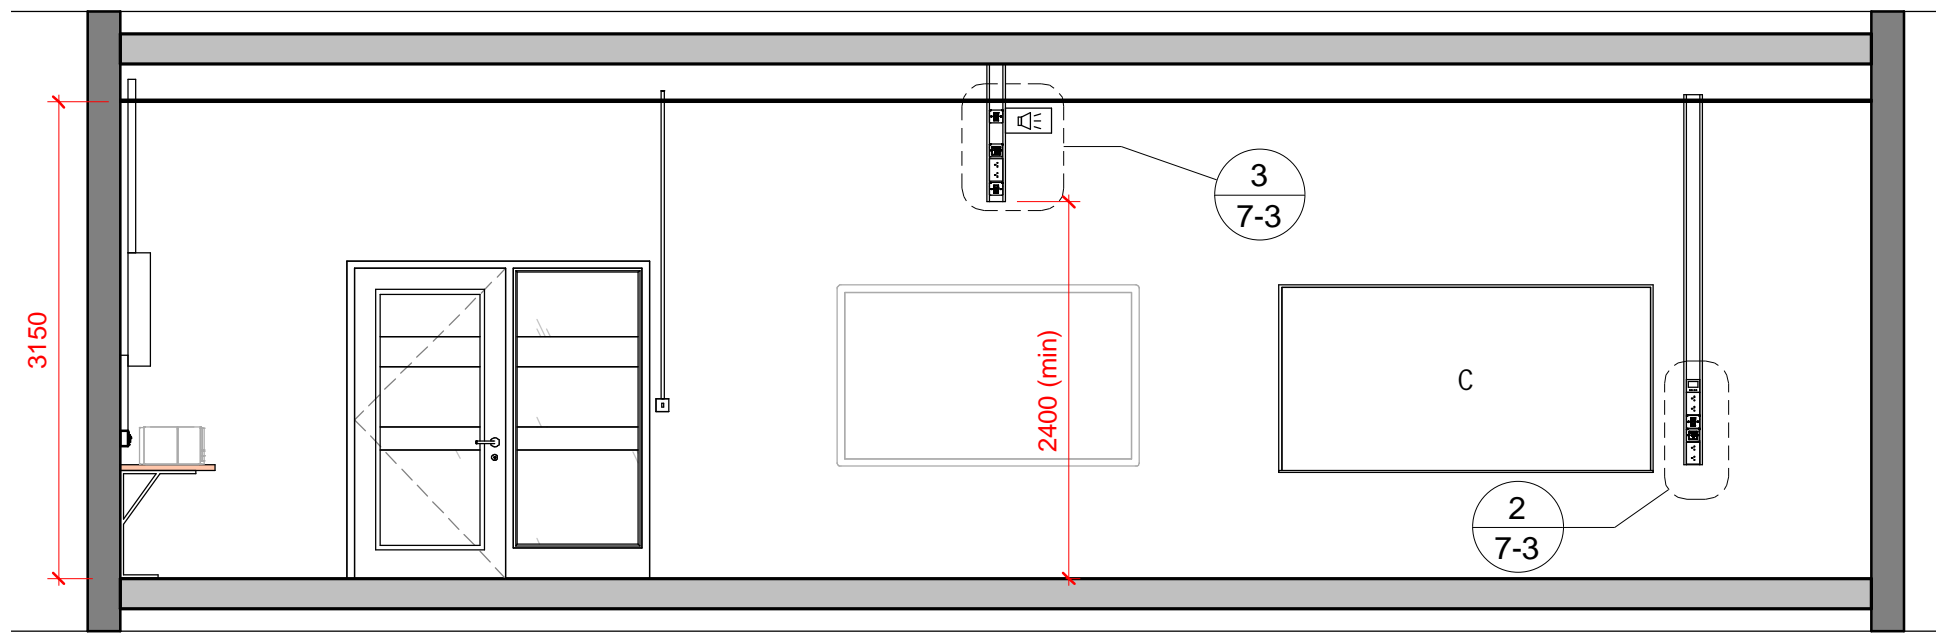


1 Elevation AA
1 : 50

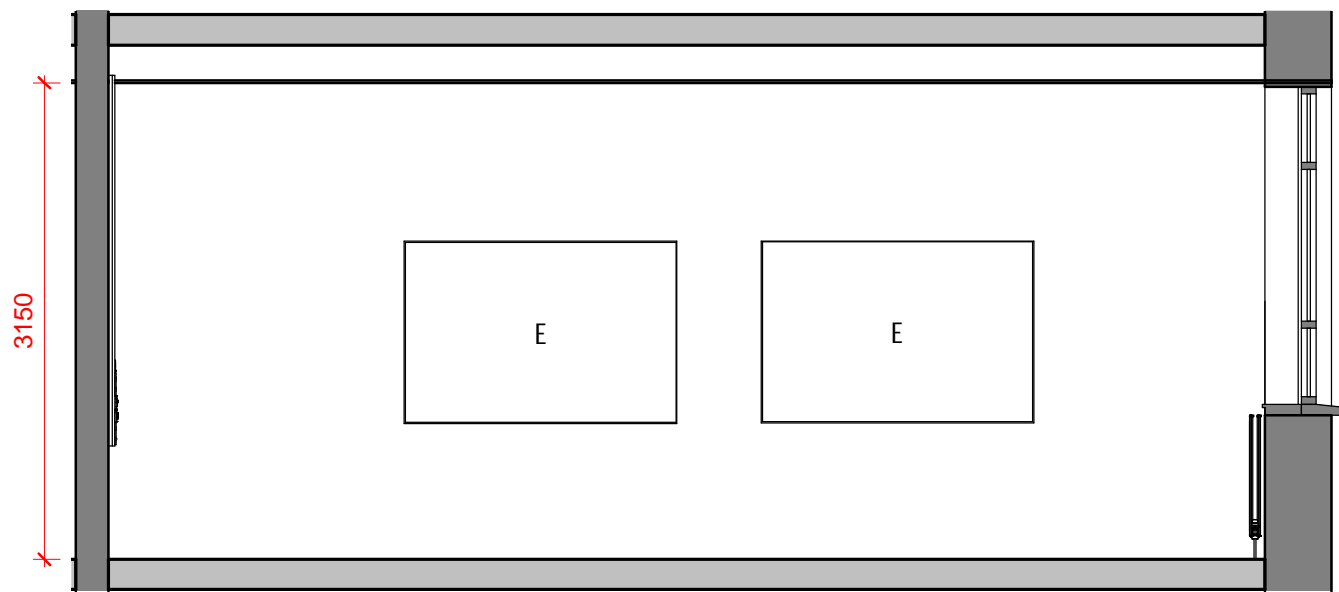

2 Elevation BB
1 : 50

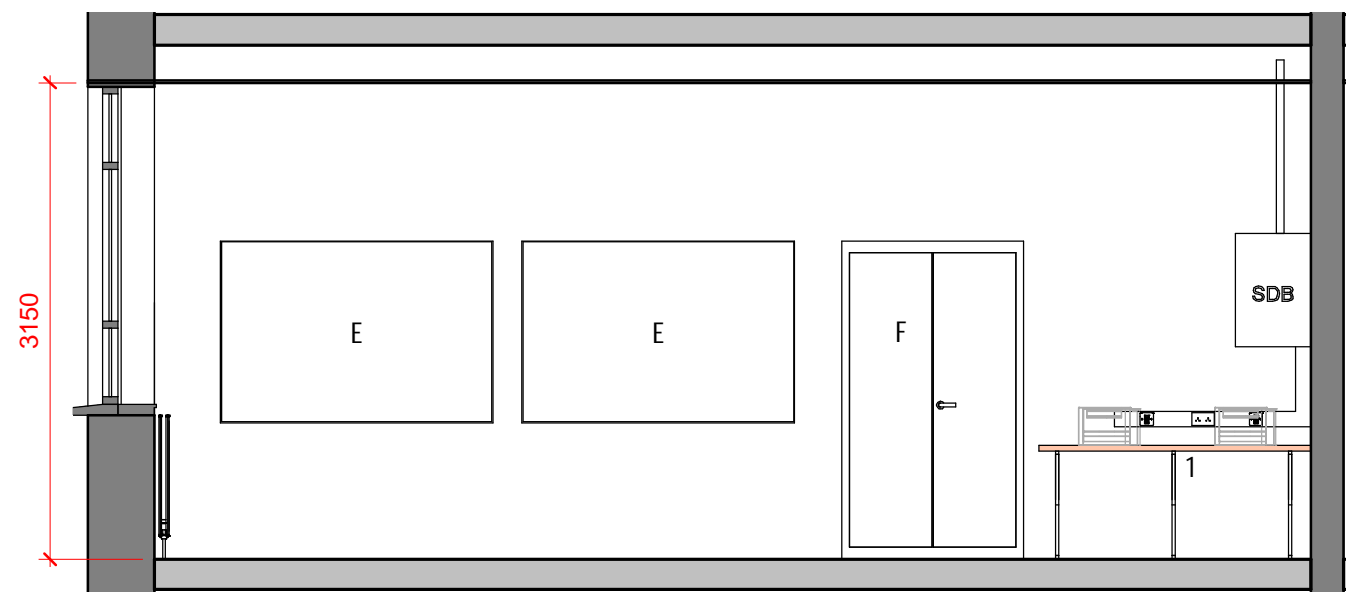

3 Elevation DD
1 : 50

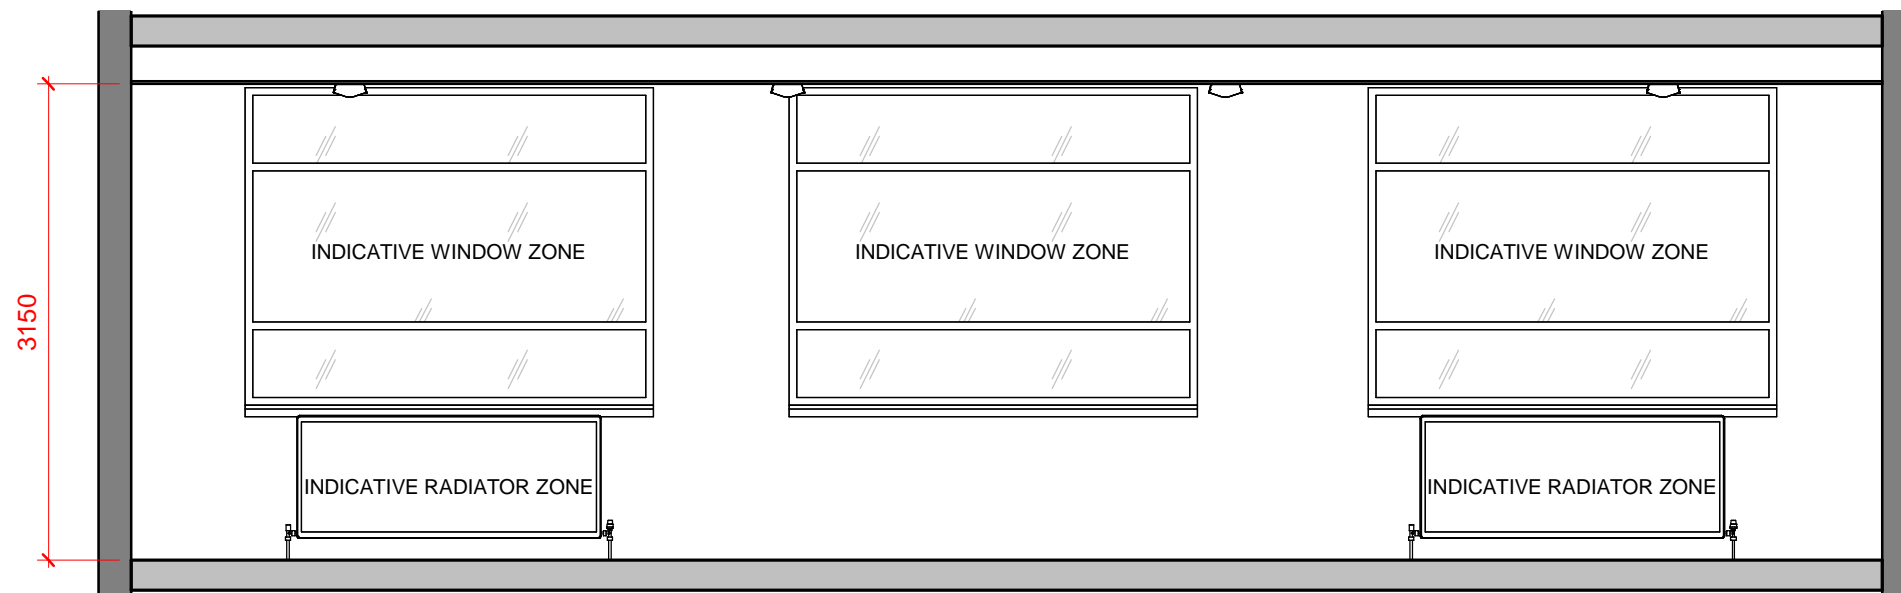


4 Elevation CC
1 : 50

Post Primary School Room Layouts:		Dwg. Title	
Technical Graphics Room		Elevations	
Dwg. No.	Rev. No.	Scale	Date
7-2		1 : 50 @ A3	Jan '17




Department of Education & Skills

Planning and Building Unit, Portlaoise Road, Tullamore, County Offaly, R35 Y2N5.
www.education.ie / www.energyineducation.ie

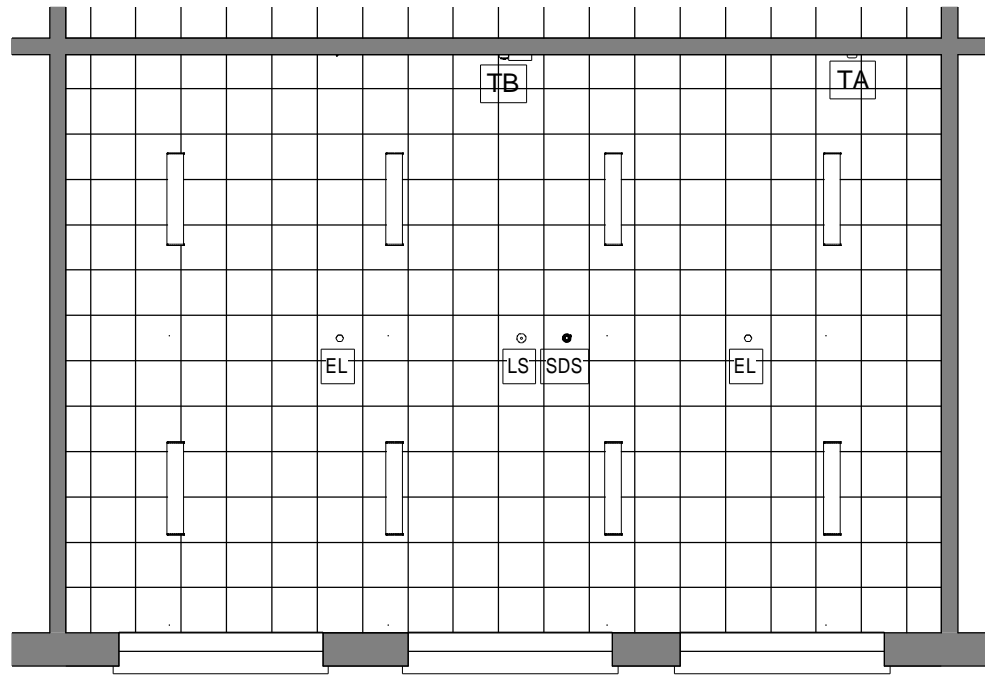


1 Indicative Ceiling Plan
1 : 100 / 500 lux

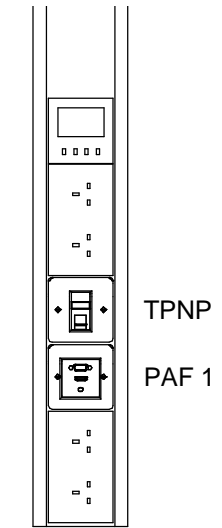


2 TA - Trunking "A"
1 : 10

BUILDING SERVICES LEGEND		
Description	Qty	
Data Projector Network Point (DPNP)	1	[Symbol]
Daylight Sensor with Absence Detector	1	[LS]
Emergency Lighting	2	[EL]
Network Point	2	[Symbol]
One Way Light Switch	1	[Symbol]
PA Loudspeaker (One Way)	1	[Symbol]
Projector/Audio In Faceplate	1	[Symbol]
Projector/Audio-out Faceplate	1	[Symbol]
Smoke Detector / Sounder	1	[SDS]
Socket Twin 13A Unswitched	4	[Symbol]
Sub Distribution Board	1	[SDB]
Teacher Position Network Point (TPNP)	1	[Symbol]
Thermostat Control	1	[Symbol]
Wireless Access Position Network Point (WAPNP)	1	[Symbol]

INDICATIVE LIGHTING SCHEDULE	
Description	Count
Surface Mounted Fluorescent	8

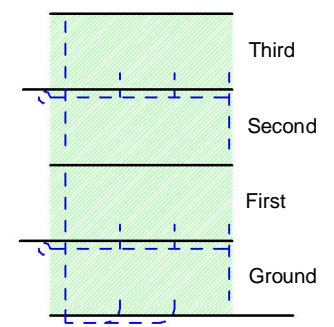

Room may be serviced from above and can be located on any level.

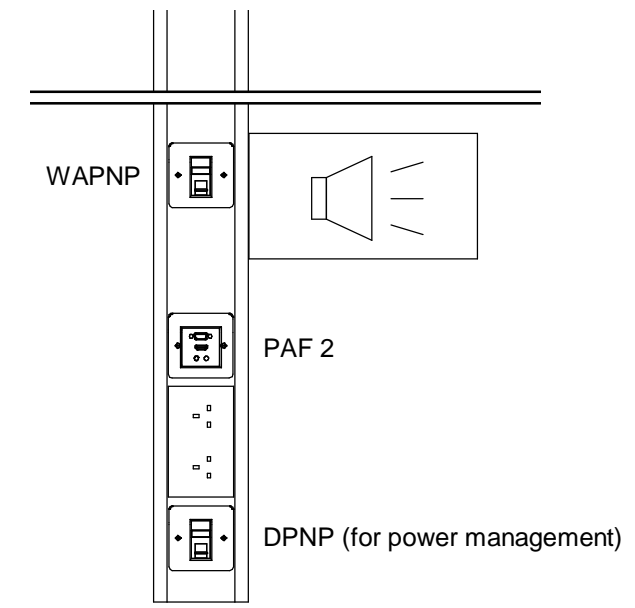

3 TB - Trunking "B"
1 : 10

Post Primary School Room Layouts:		Dwg. Title	
Technical Graphics Room		Ceiling Plan	
Dwg. No. 7-3	Rev. No.	Scale As indicated @ A3	Date Jan '17

