

1 Floor Plan
1 : 50 / 88.6 sq.m / 38.46 sq.m


LOOSE FURNITURE SCHEDULE			
Key	Description	Quantity	Code
A	Student Project Table	11	SPT
B	Adjustable Worktop (Manual)	1	CWT
C	Steel Press 900 x 450 x 1800h	1	N
D	Teacher's chair 525 high	1	S5
E	Pinboard 1200x1200	3	PB
F	Filing Cabinet 4 Drawer	1	N
G	Storage Trolley	1	STS T
H	Fridgefreezer 600x600x150 high	1	FFR
J	Storage Unit 450 x 600 x 700h	2	ST1
K	Student High Stool 660h	24	S2H

FIXED FURNITURE			
Key	Description	Quantity	Code
1	Teaching Wall Unit 5350 with desk 450D	1	TW
2	Student's pedestal unit 600x700x1020 h with science sink	5	PU1
3	Tray Storage System 2-row 1800h	6	TSS
4	Storage Unit with Sliding Doors	1	SUS
5	High level storage 1200x600	3	HL6
6	Island with Tray Storage System 1480x900	1	N10
7	Counter top 4200x600x740h with casework	1	N10
8	Counter top 2400x600x740h with casework	1	N10
9	Counter top 2400x600 740h with science sink and casework	1	N10
10	Tray Storage System 3-row 1800h.	6	TSS
11	Shelving Unit L-shaped 350 deep	1	SU1
12	Belfast sink 900x455 (H&C supply)	2	BS
13	Science Lab Pedestal Wheelchair Accessible	1	PU2


SPECIALITY EQUIPMENT SCHEDULE			
Key	Description	Quantity	Code
AA	Fume cupboard 1200x600 approx	1	FC
BB	Dishwasher	1	DW

Post Primary School Room Layouts:			Dwg. Title	
Science Lab & Science Prep			Floor Plan	
Dwg. No.	Rev. No.	Scale	Date	
8/9-1		1 : 50 @ A3	Jan '17	




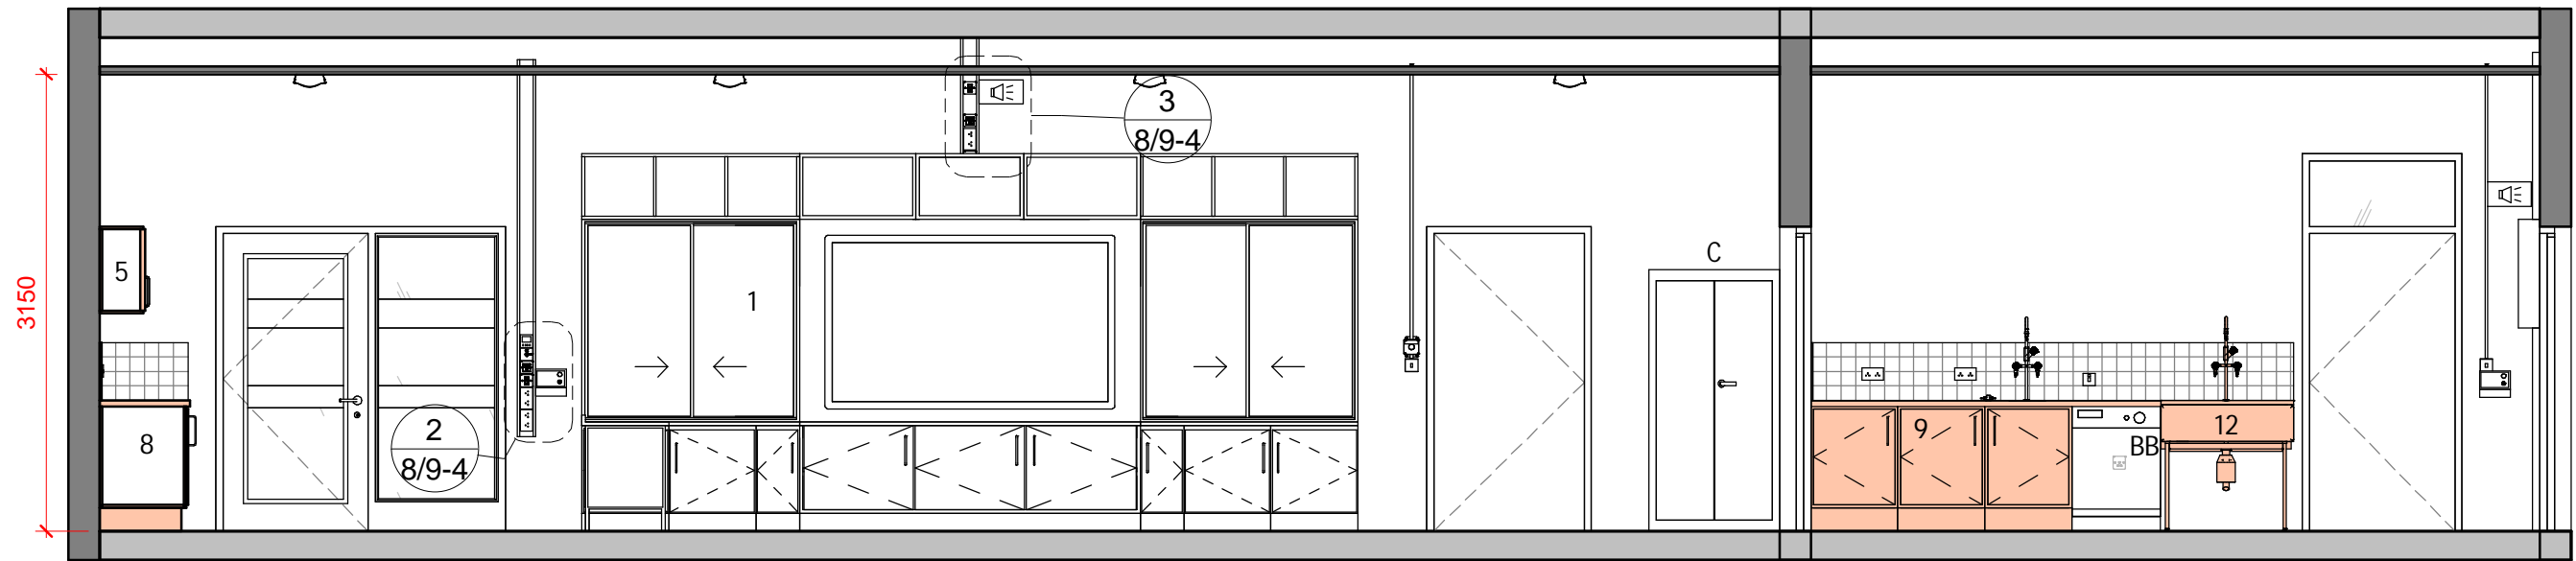


1 Elevation AA
1 : 50

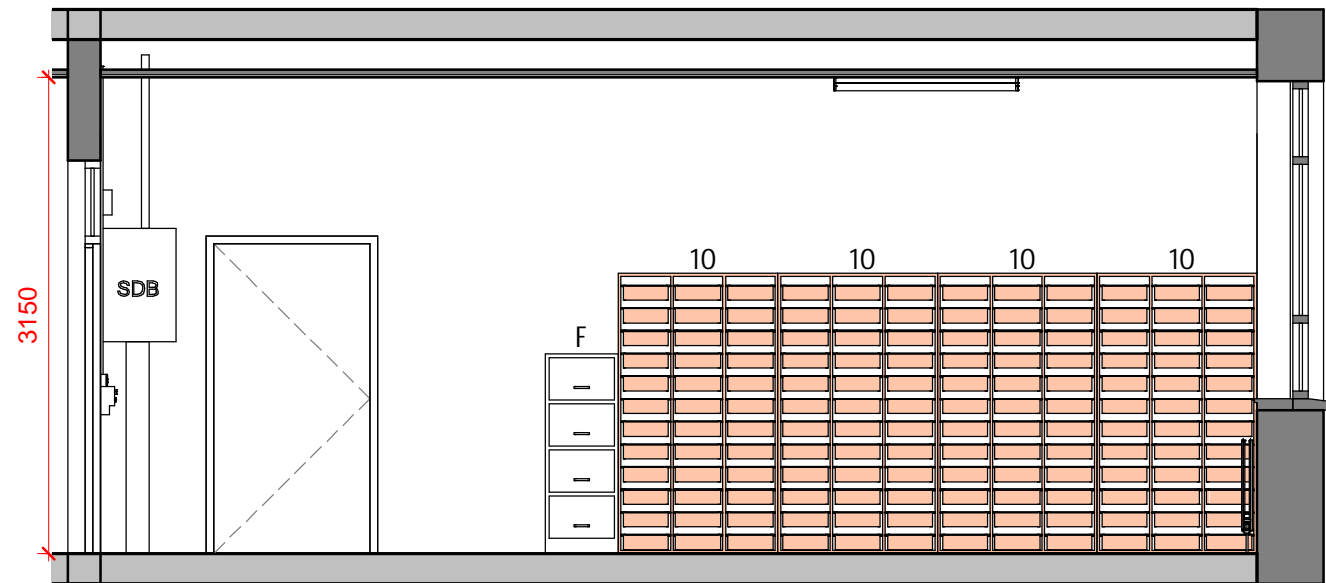


2 Prep Room Elevation EE
1 : 50

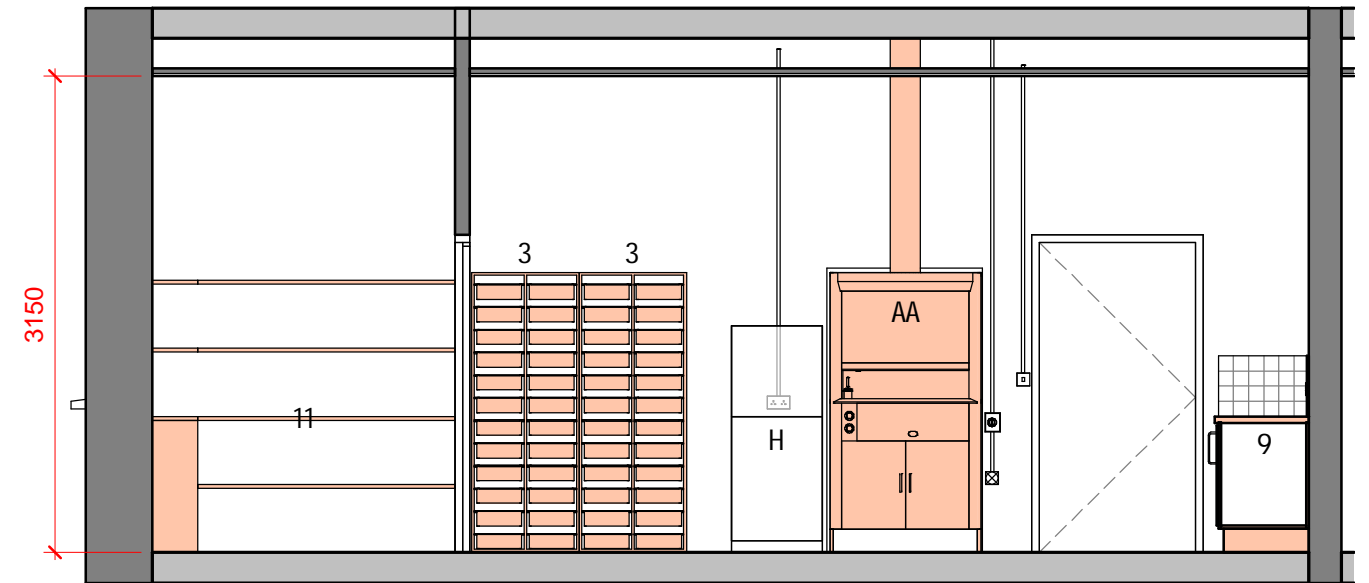


3 Prep Room Elevation FF
1 : 50

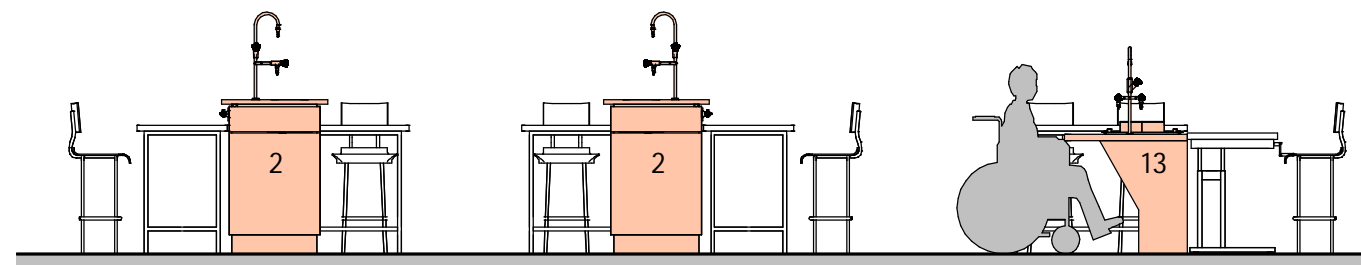


4 Student Stations
1 : 50

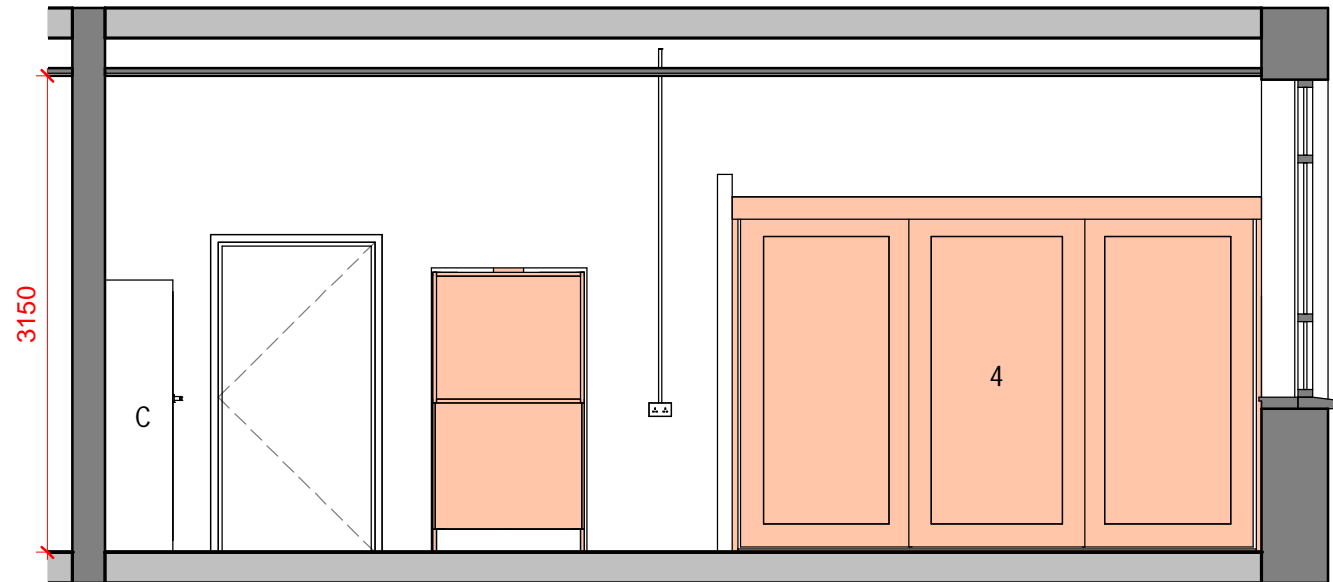


1 Elevation BB
1 : 50

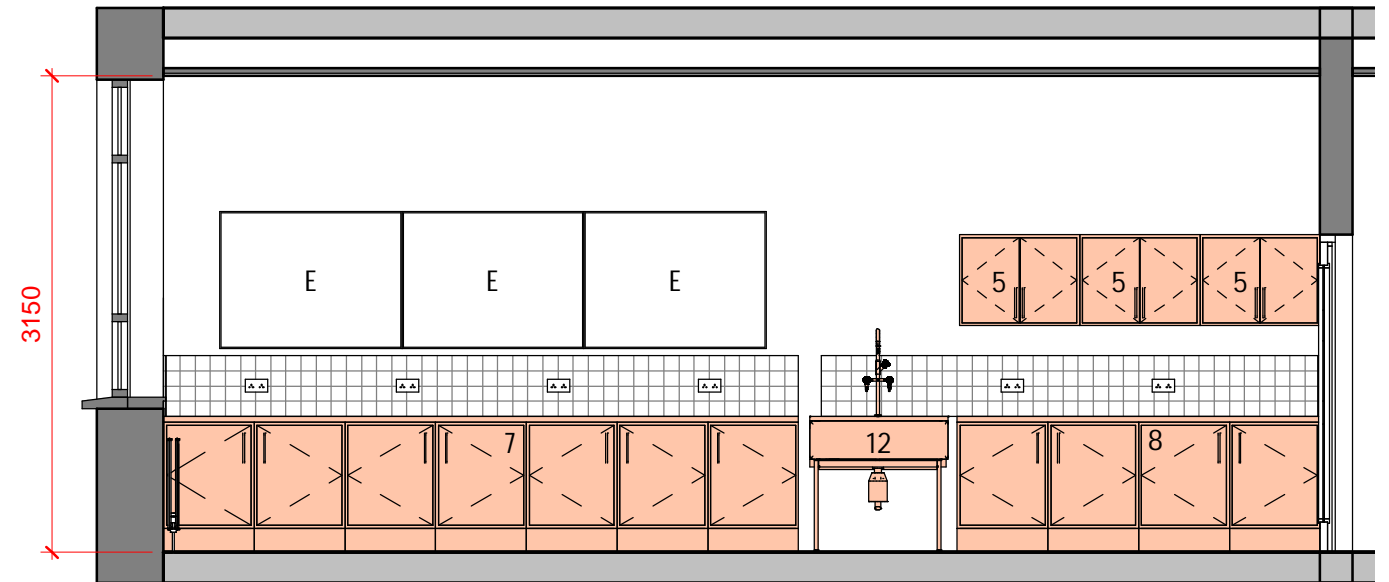

2 Elevation DD
1 : 50

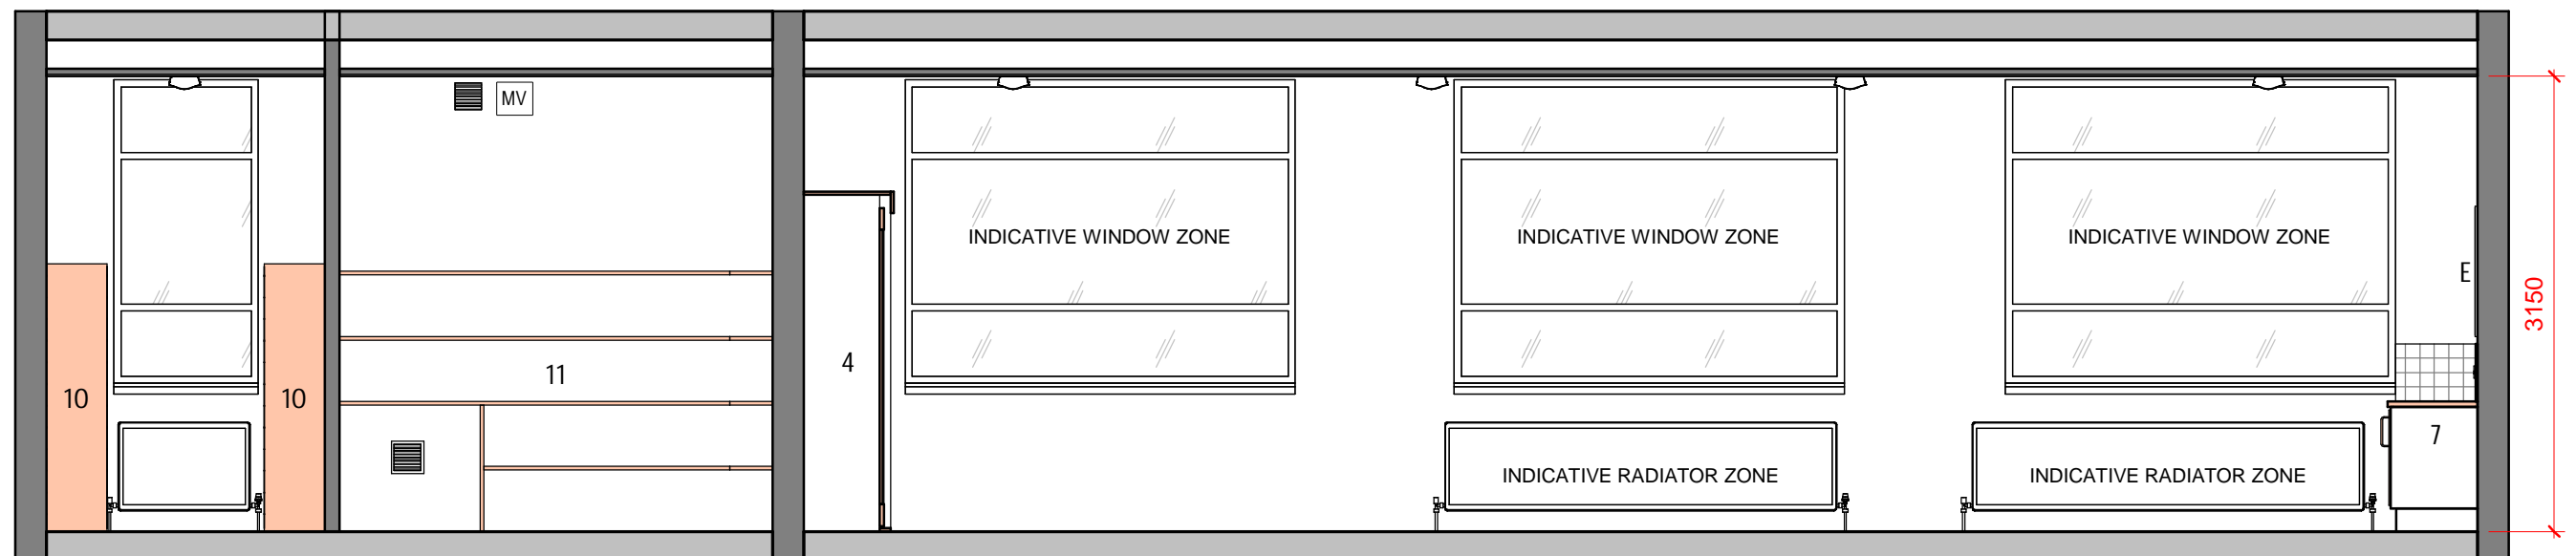


3 Elevation CC
1 : 50

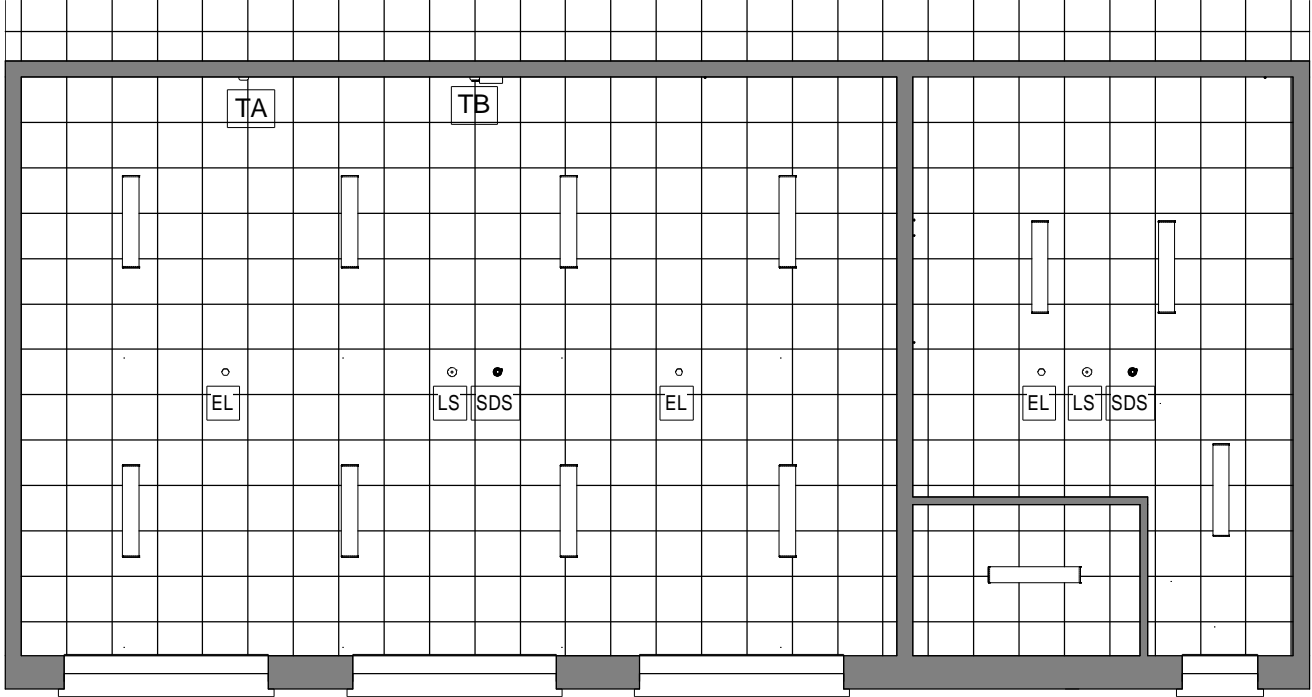


1 Indicative Ceiling Plan
1 : 100 / 500 lux

BUILDING SERVICES LEGEND		
Description	Qty	
Data Projector Network Point (DPNP)	1	
Daylight Sensor with Absence Detector	2	
Emergency Gas Knockout	1	
Emergency Lighting	3	
Gas Proving Unit	2	
Keyed Isolation Switch	1	
Mechanical Ventilation (Fan)	1	
One Way Light Switch	4	
PA Loudspeaker (One Way)	2	
Projector/Audio In Faceplate	1	
Projector/Audio-out Faceplate	1	
Single Phase Rotary Switch	1	
Smoke Detector / Sounder	2	
Socket Single 13A Unswitched	1	
Socket Twin 13A Unswitched	26	
Sub Distribution Board	1	
Switch with Neon	1	
Teacher Position Network Point (TPNP)	1	
Thermostat Control	1	
Timer (for Chemical Store Light)	1	
Wireless Access Position Network Point (WAPNP)	1	


INDICATIVE LIGHTING SCHEDULE	
Description	Count
Surface Mounted Fluorescent	12

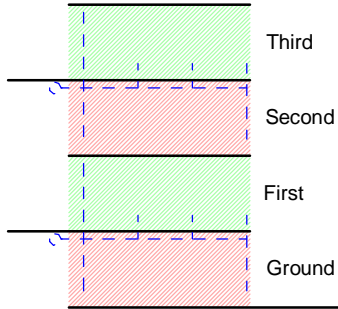

The preferred location for this bottom serviced room is on the first or third floor.

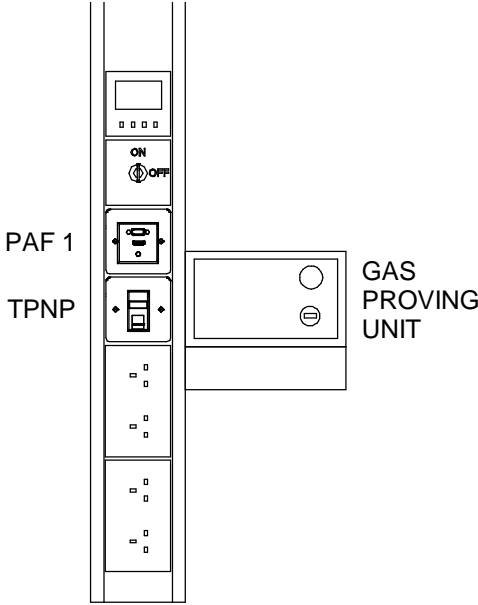

2 TA - Trunking "A"
1 : 10

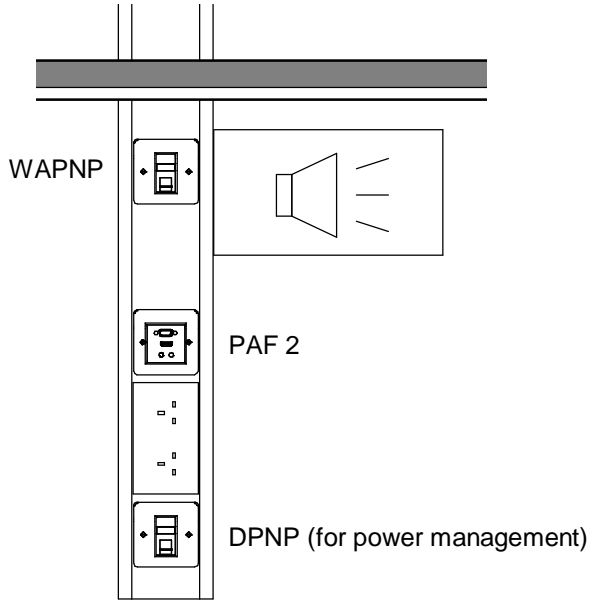

3 TB - Trunking "B"
1 : 10