

**1 Floor Plan**  
1 : 50 / 88.60 sq.m.

LOOSE FURNITURE SCHEDULE			
Key	Description	Quantity	Code
A	Student Project Table	12	SPT
B	Polypropylene Chair 600 high (Stackable)	10	SIEO
C	Student High Stool 660h	24	S2H
D	Teacher's chair 525 high	1	S5

FITTED FURNITURE SCHEDULE			
Key	Description	Quantity	Code
1	Teaching Wall Unit 4800mm with Tall Larder	1	TWU
2	Textile Room Workstation	10	TRW
3	Adjustable Worktop (manual) with sink (cold water only)	1	SSU


SPECIALITY EQUIPMENT SCHEDULE			
Key	Description	Quantity	Code

Post Primary School Room Layouts:		Dwg. Title	
<b>Textile Room</b>		<b>Floor Plan</b>	
Dwg. No. <b>13-1</b>	Rev. No.	Scale <b>1 : 50 @ A3</b>	Date <b>Jan '17</b>




**Department of Education & Skills**


Planning and Building Unit, Portlaoise Road, Tullamore, County Offaly, R35 Y2N5.  
www.education.ie / www.energineducation.ie

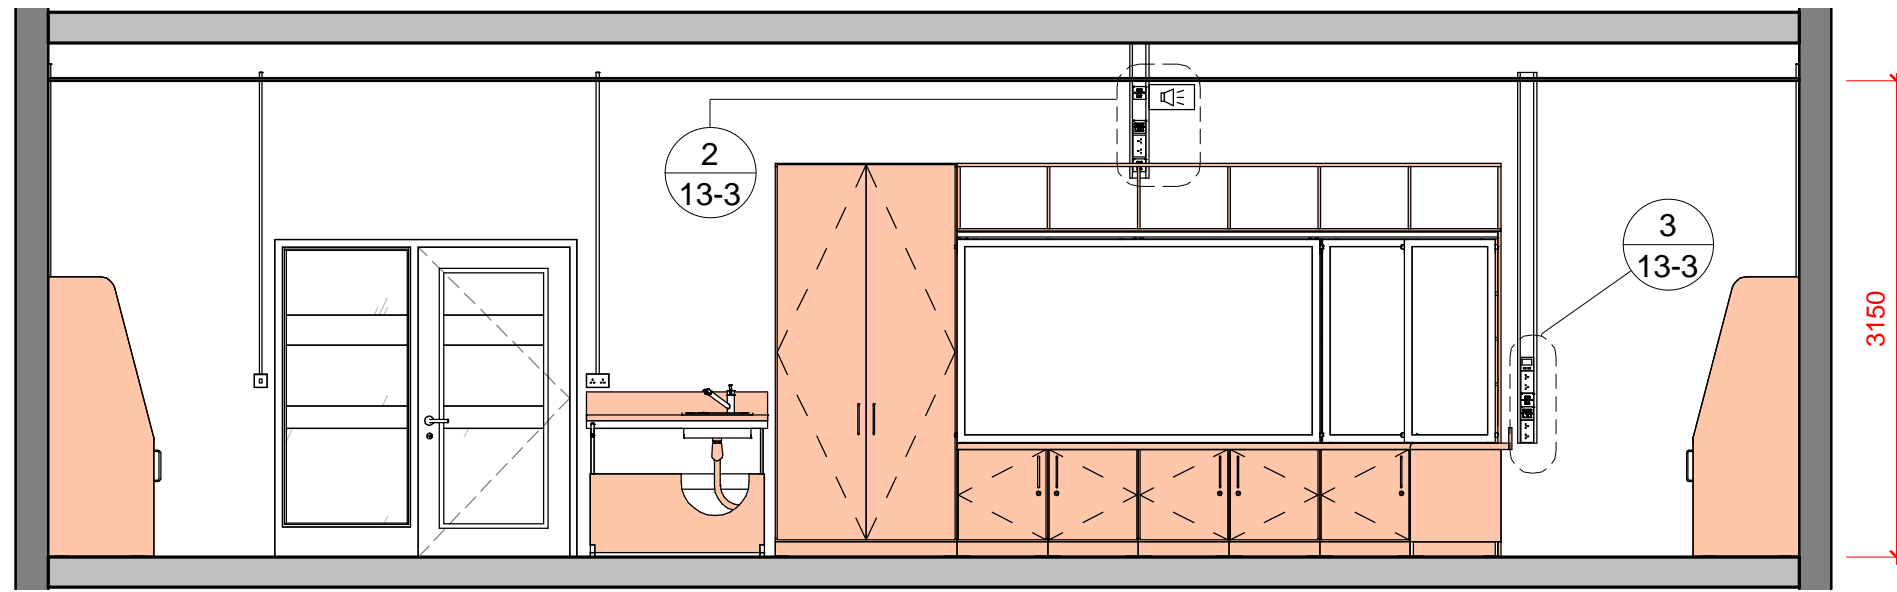


**1** Elevation AA  
1 : 50

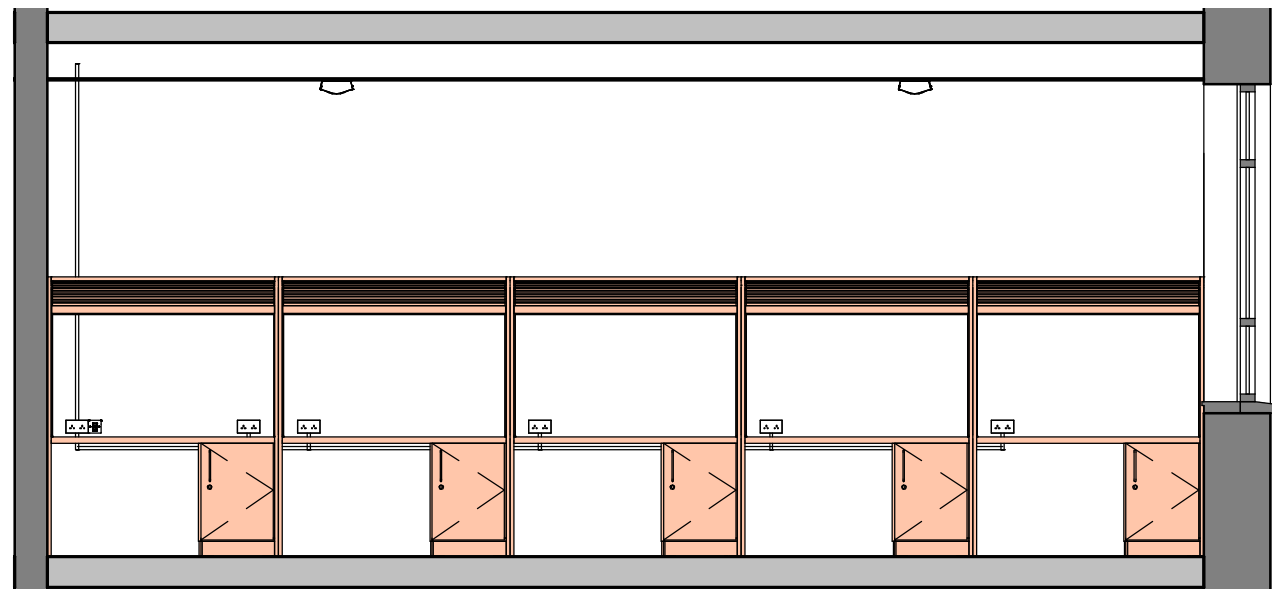

**2** Elevation BB  
1 : 50

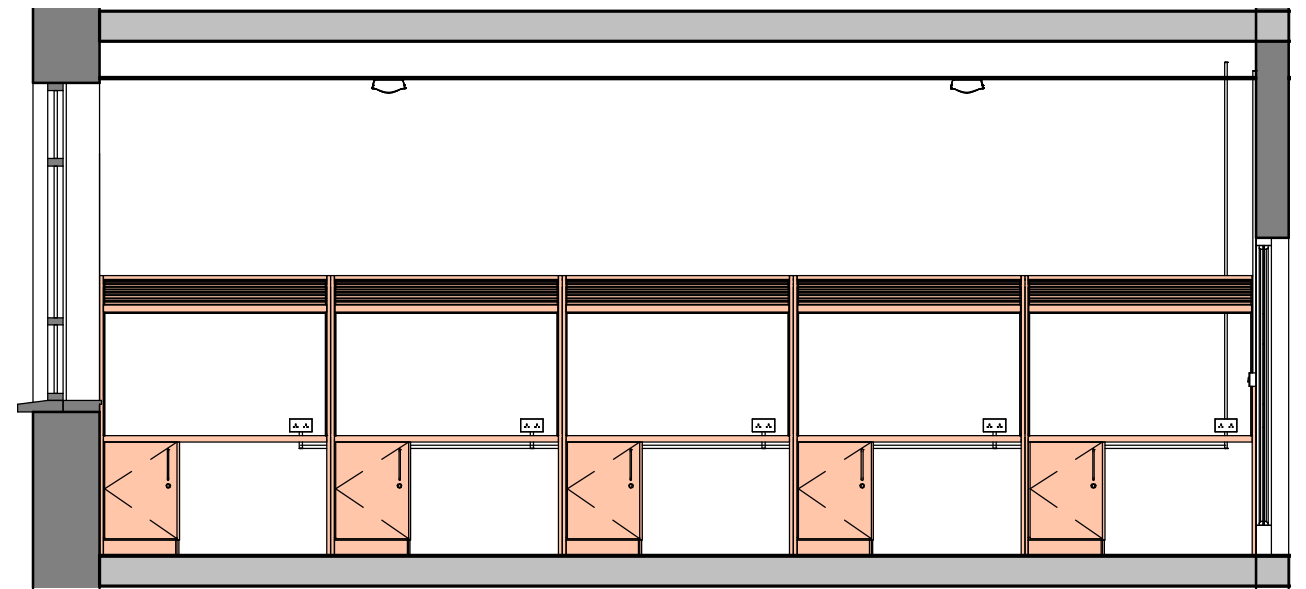

**3** Elevation DD  
1 : 50

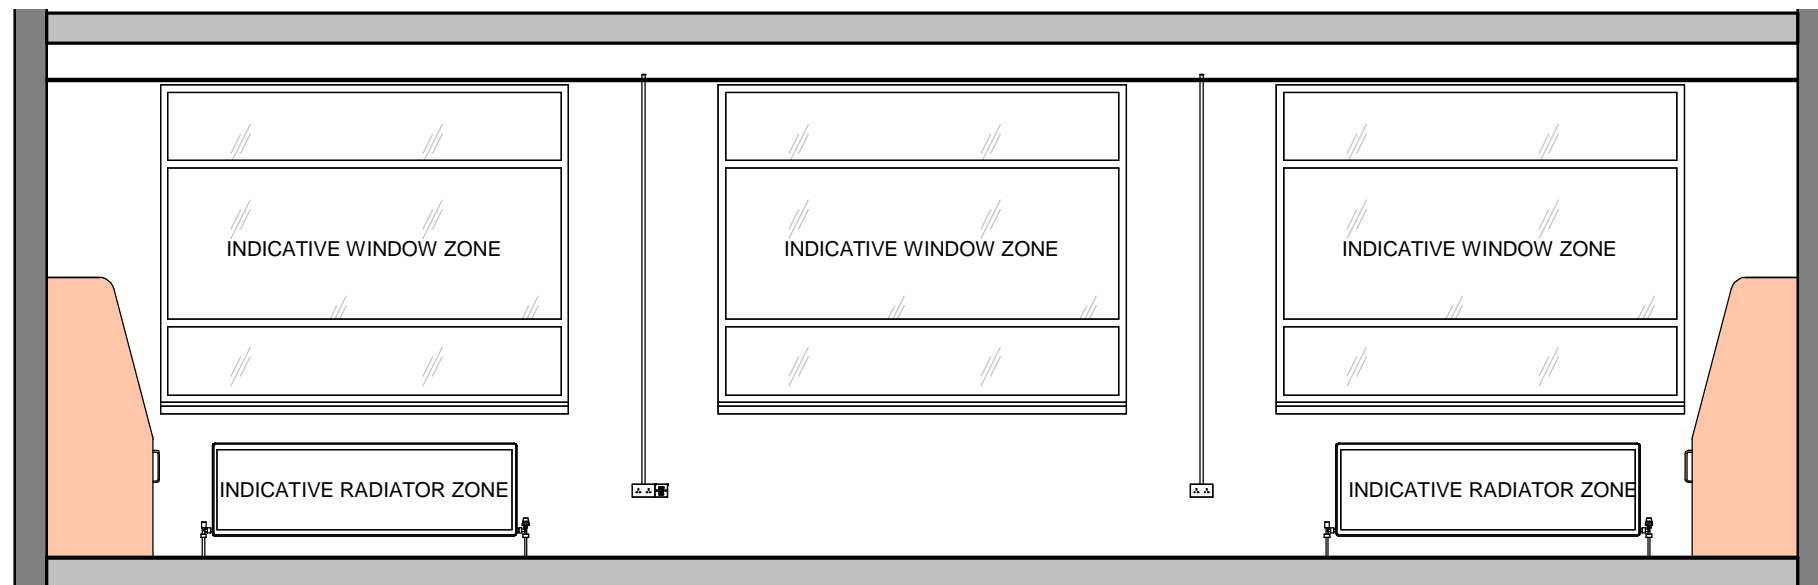


**4** Elevation CC  
1 : 50

Post Primary School Room Layouts:		Dwg. Title	
<b>Textile Room</b>		<b>Elevations</b>	
Dwg. No. <b>13-2</b>	Rev. No.	Scale <b>1 : 50 @ A3</b>	Date <b>Jan '17</b>




**Department of Education & Skills**


Planning and Building Unit, Portlaoise Road, Tullamore, County Offaly, R35 Y2N5.  
www.education.ie / www.energyineducation.ie

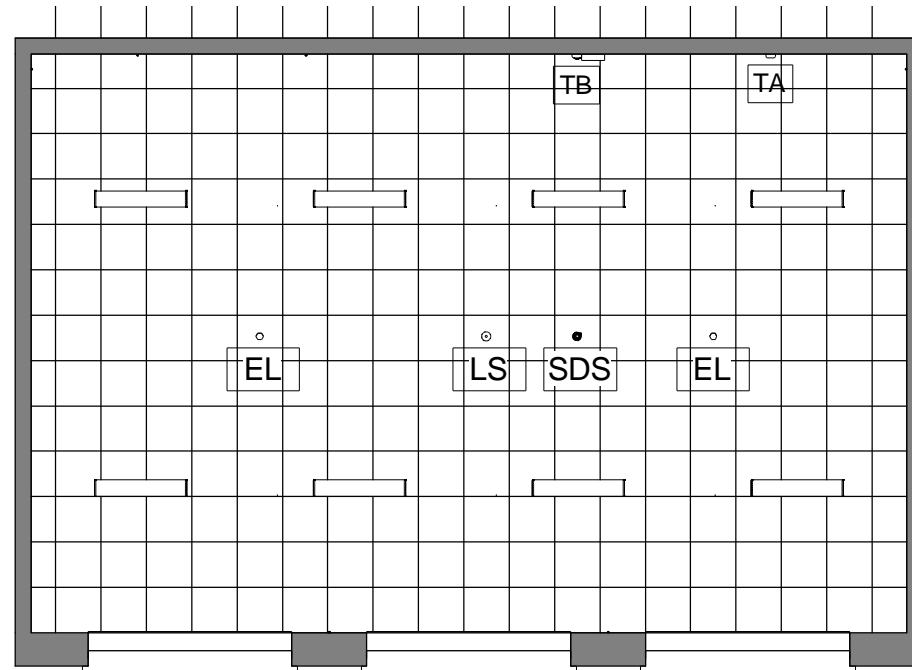

**1 Indicative Ceiling Plan**  
1 : 100 / 500 lux

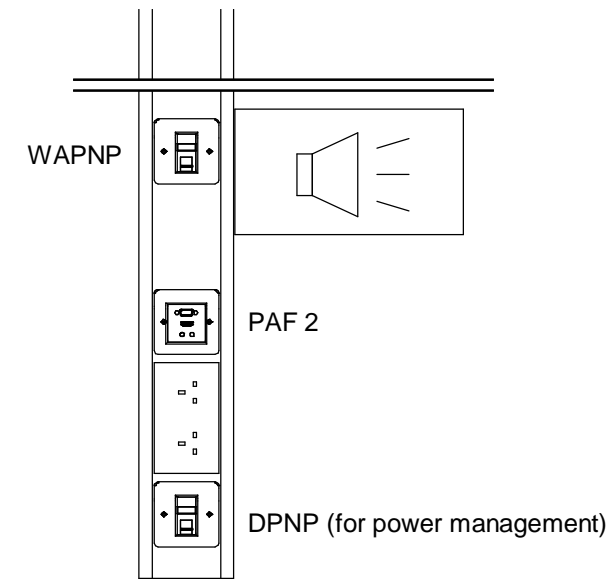


**2 TB - Trunking "B"**  
1 : 10

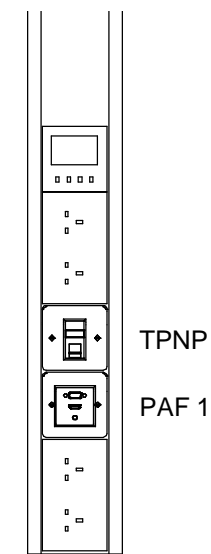

**3 TA - Trunking "A"**  
1 : 10

BUILDING SERVICES LEGEND		
Description	Qty	
Data Projector Network Point (DPNP)	1	
Emergency Lighting	2	
Network Point	2	
One Way Light Switch	1	
PA Loudspeaker (One Way)	1	
Passive Detector	1	
Projector/Audio In Faceplate	1	
Projector/Audio-out Faceplate	1	
Smoke Detector / Sounder	1	
Socket Twin 13A Unswitched	17	
Teacher Position Network Point (TPNP)	1	
Thermostat Control	1	
Wireless Access Position Network Point (WAPNP)	1	

INDICATIVE LIGHTING SCHEDULE		
Description	Qty	
Surface Mounted Fluorescent	8	

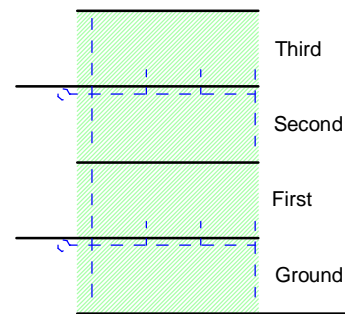

This room can be bottom or top serviced.

Post Primary School Room Layouts:		Dwg. Title	
<b>Textile Room</b>		<b>Ceiling Plan</b>	
Dwg. No. <b>13-3</b>	Rev. No.	Scale <b>As indicated @ A3</b>	Date <b>Jan '17</b>



**Department of Education & Skills**

Planning and Building Unit, Portlaoise Road, Tullamore, County Offaly, R35 Y2N5.  
www.education.ie / www.energineducation.ie